

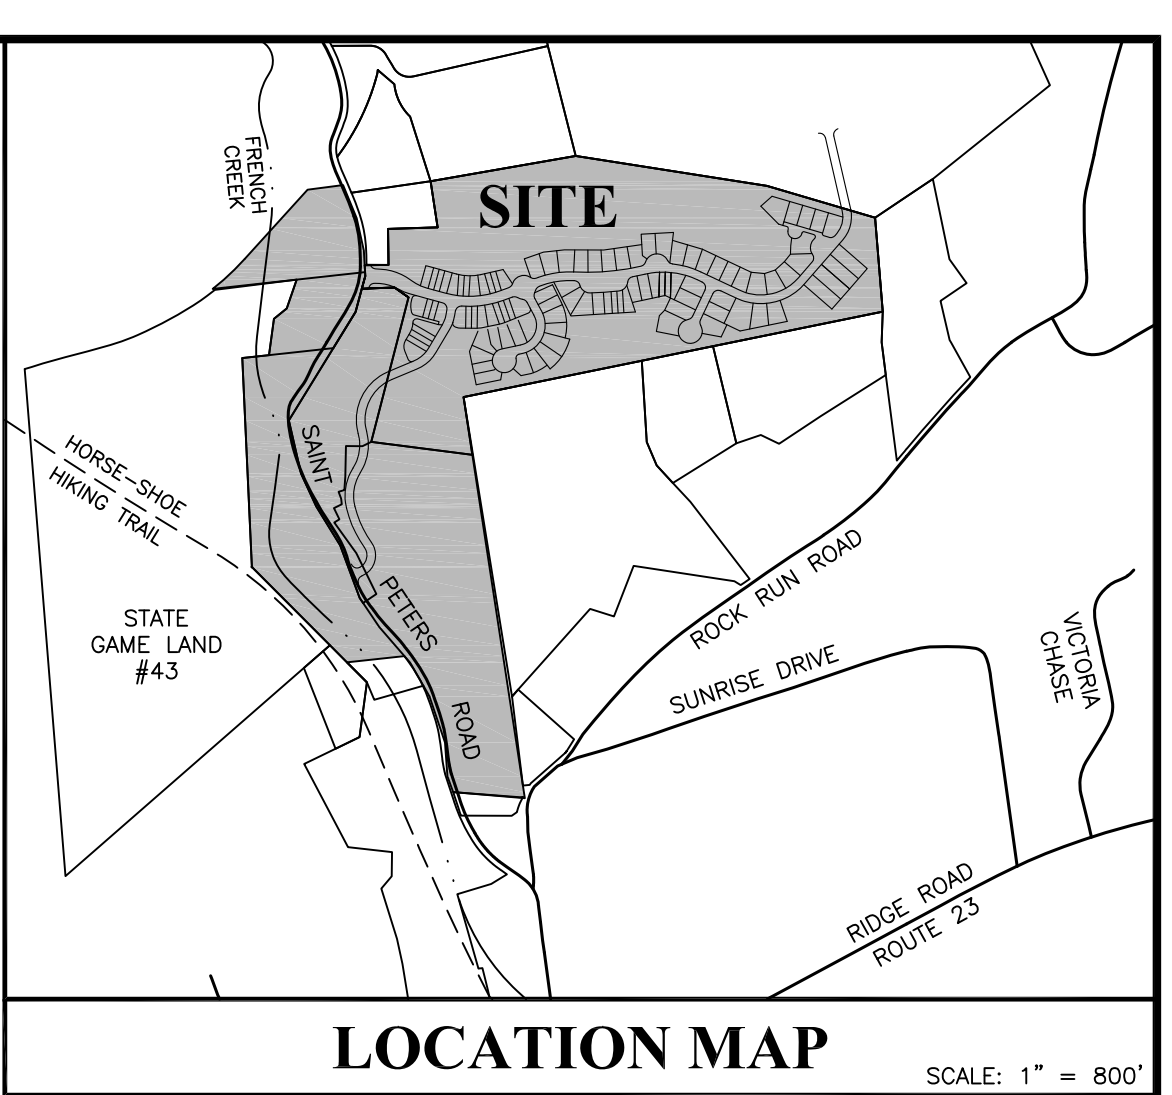
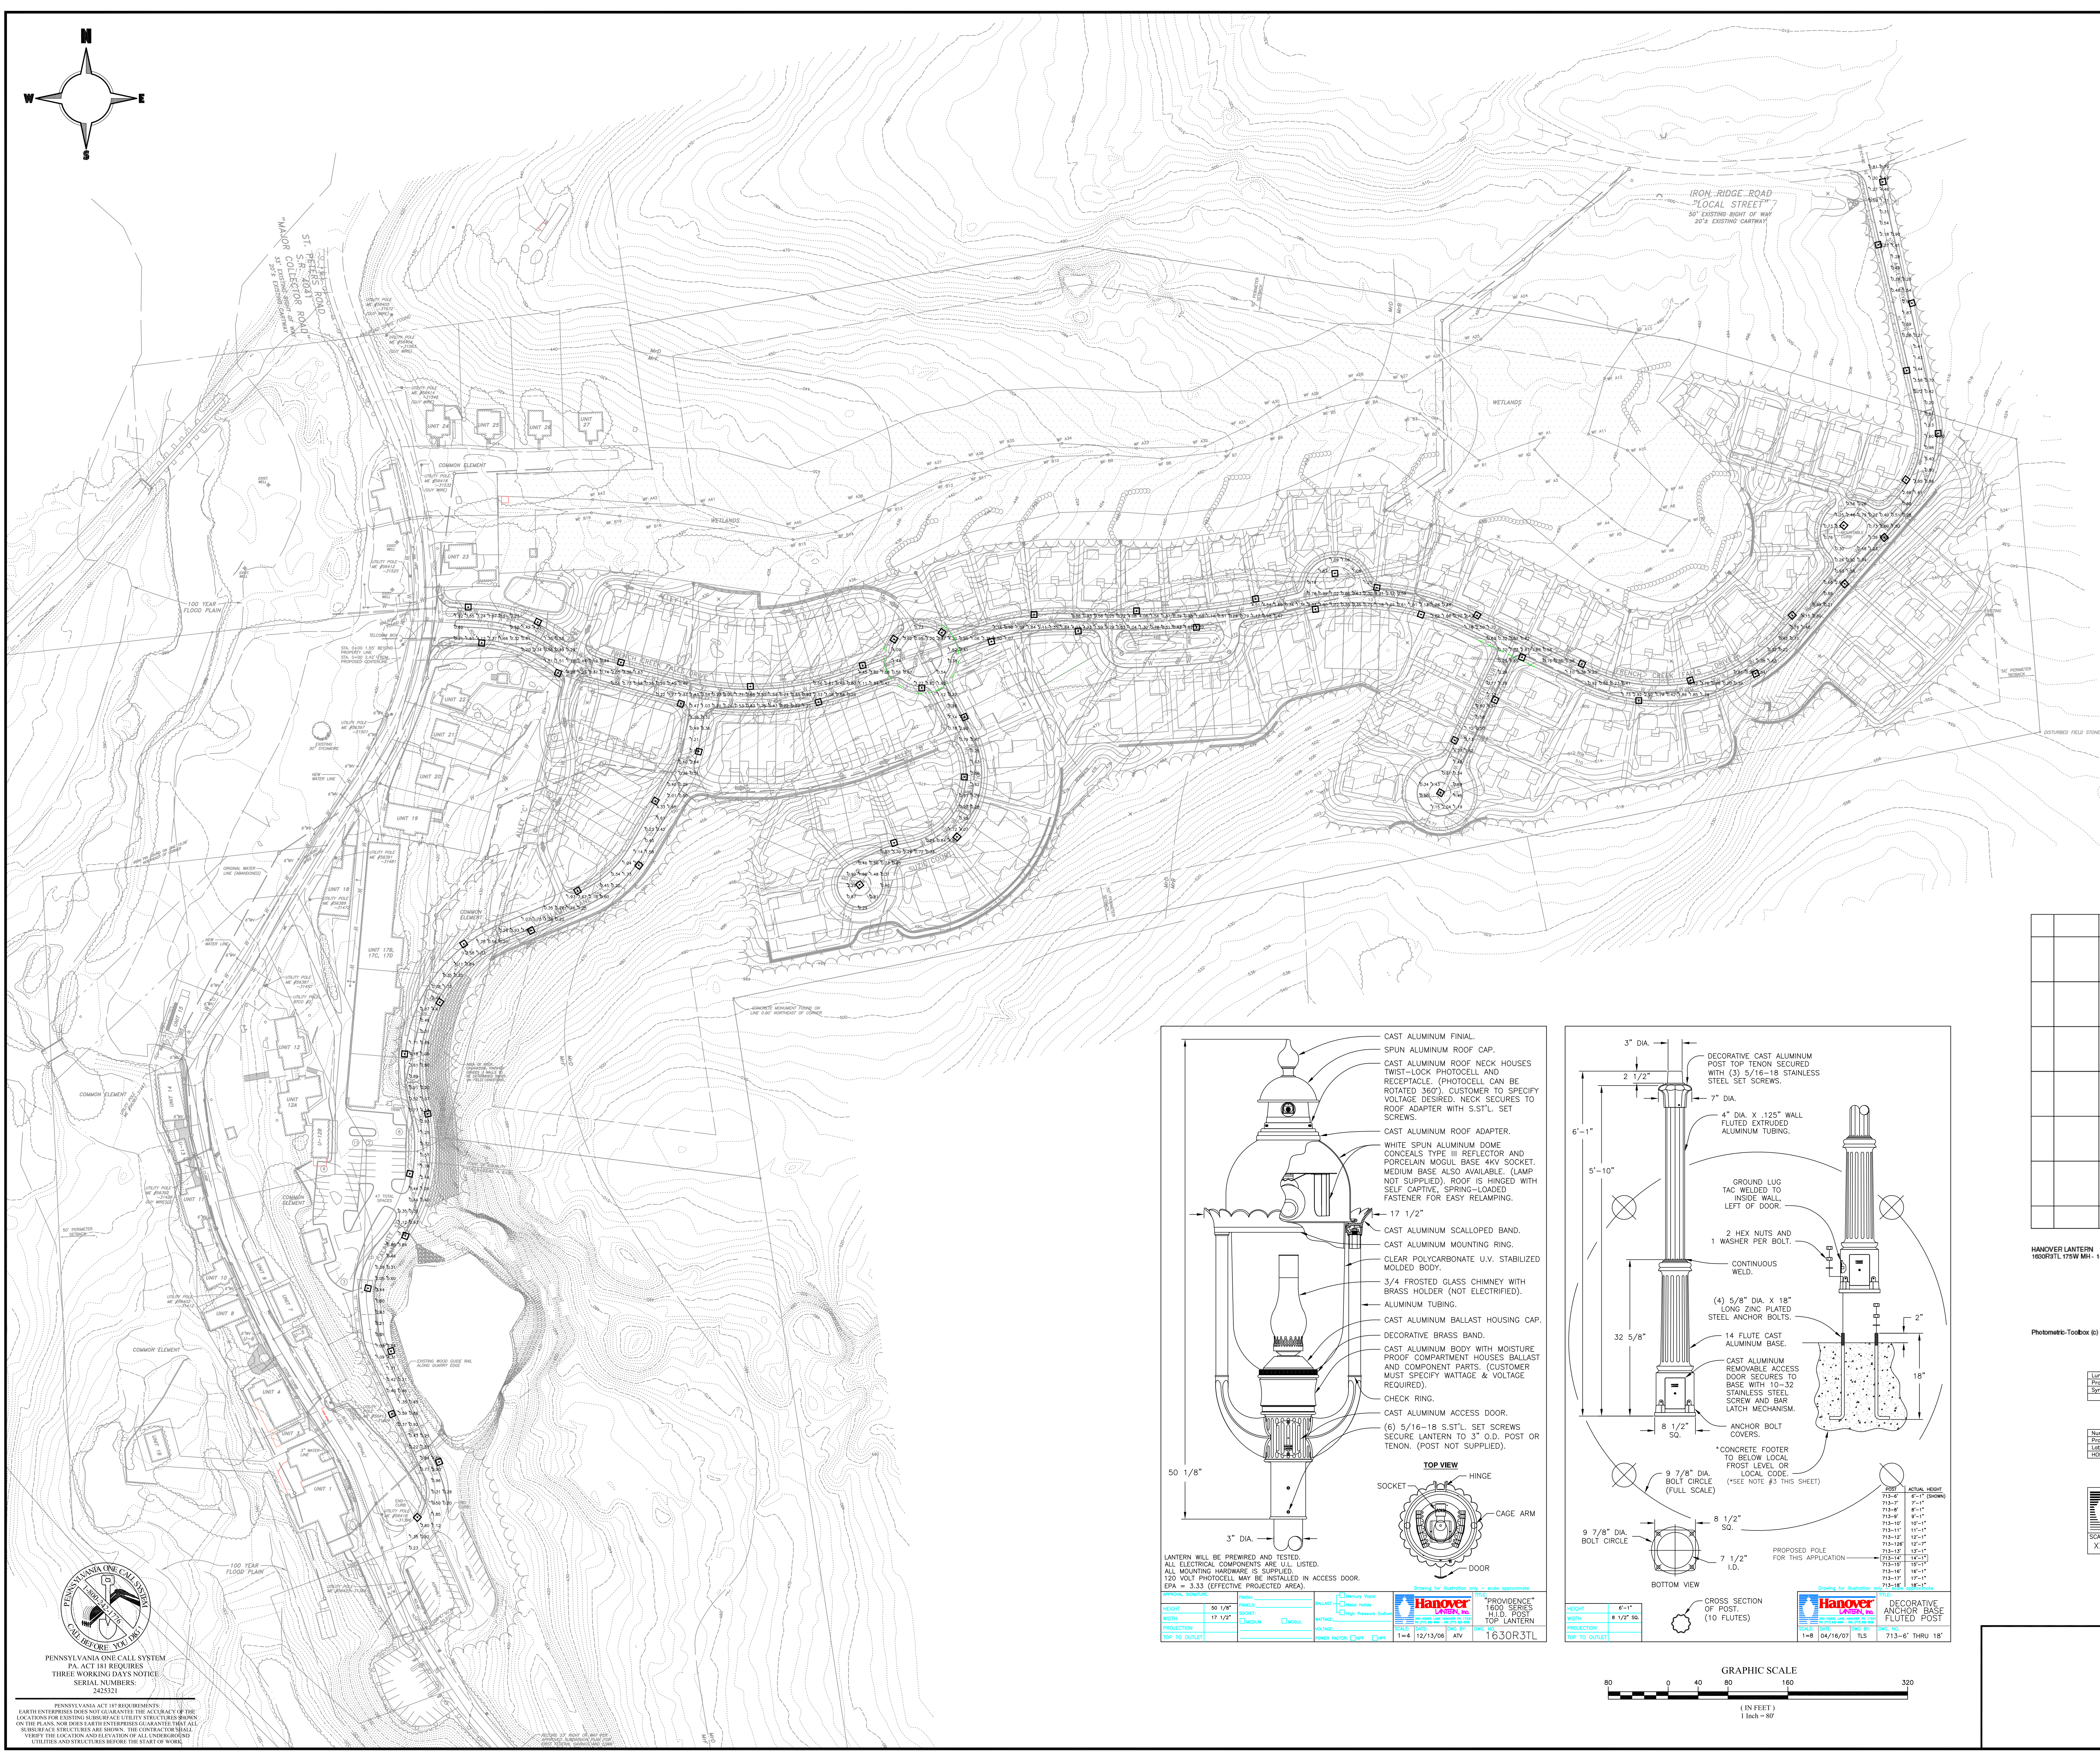
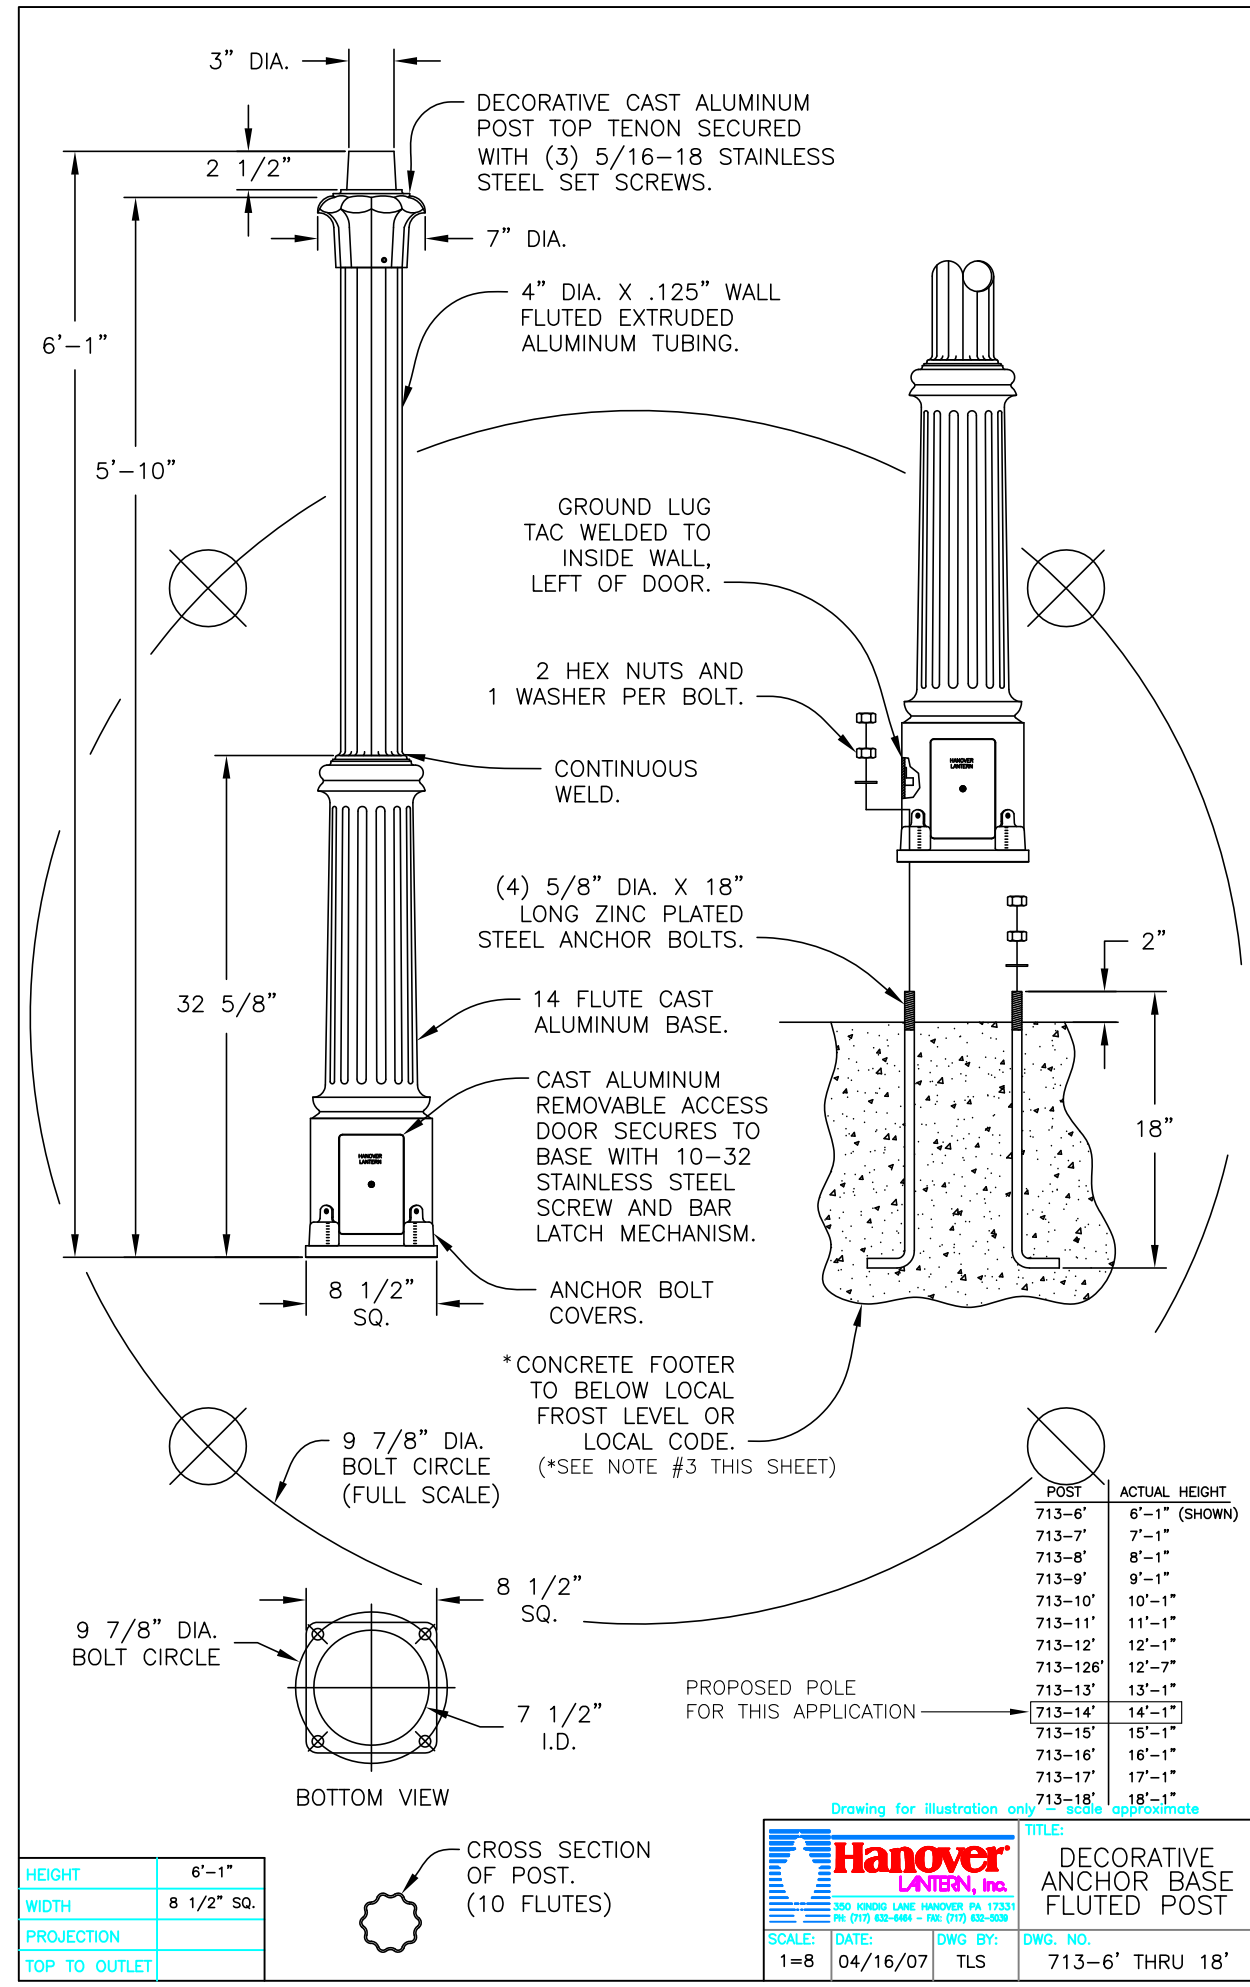


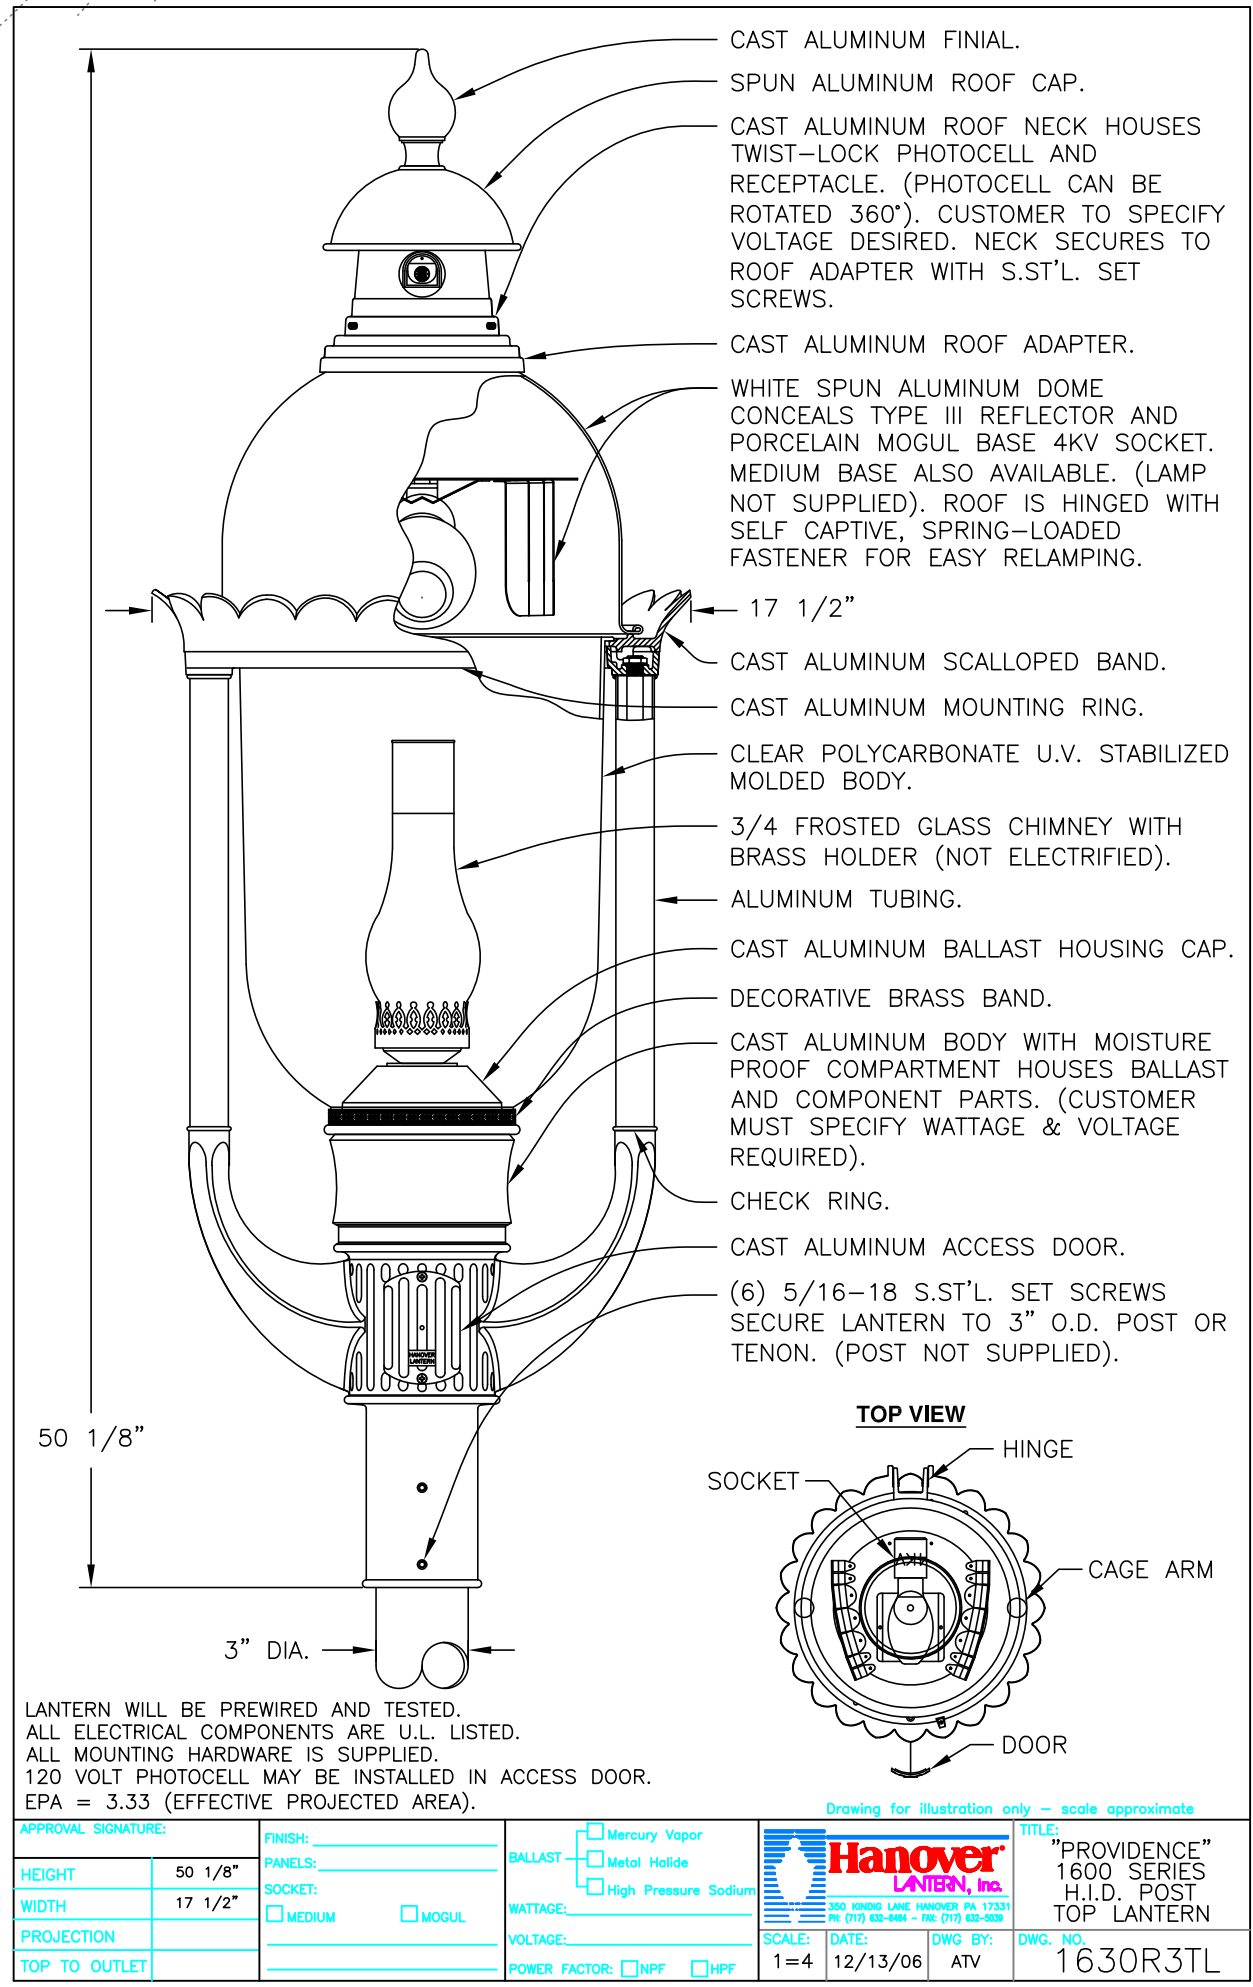

- Notes:
1. Warwick Township reserves the right to conduct one or more nighttime site inspections to assess conformance with approved lighting plans and if appropriate, to require remedial action at no expense to the Township.
 2. Revisions to the approved lighting plan or intended substitutions for specified lighting equipment shall be submitted to the Township for review and approval prior to installation.
 3. Lamp post foundation shall be a minimum of 15" in diameter and extend to 36" below grade or to competent bedrock to prevent frost heaving. All concrete shall have a minimum 3500 psi compressive strength.

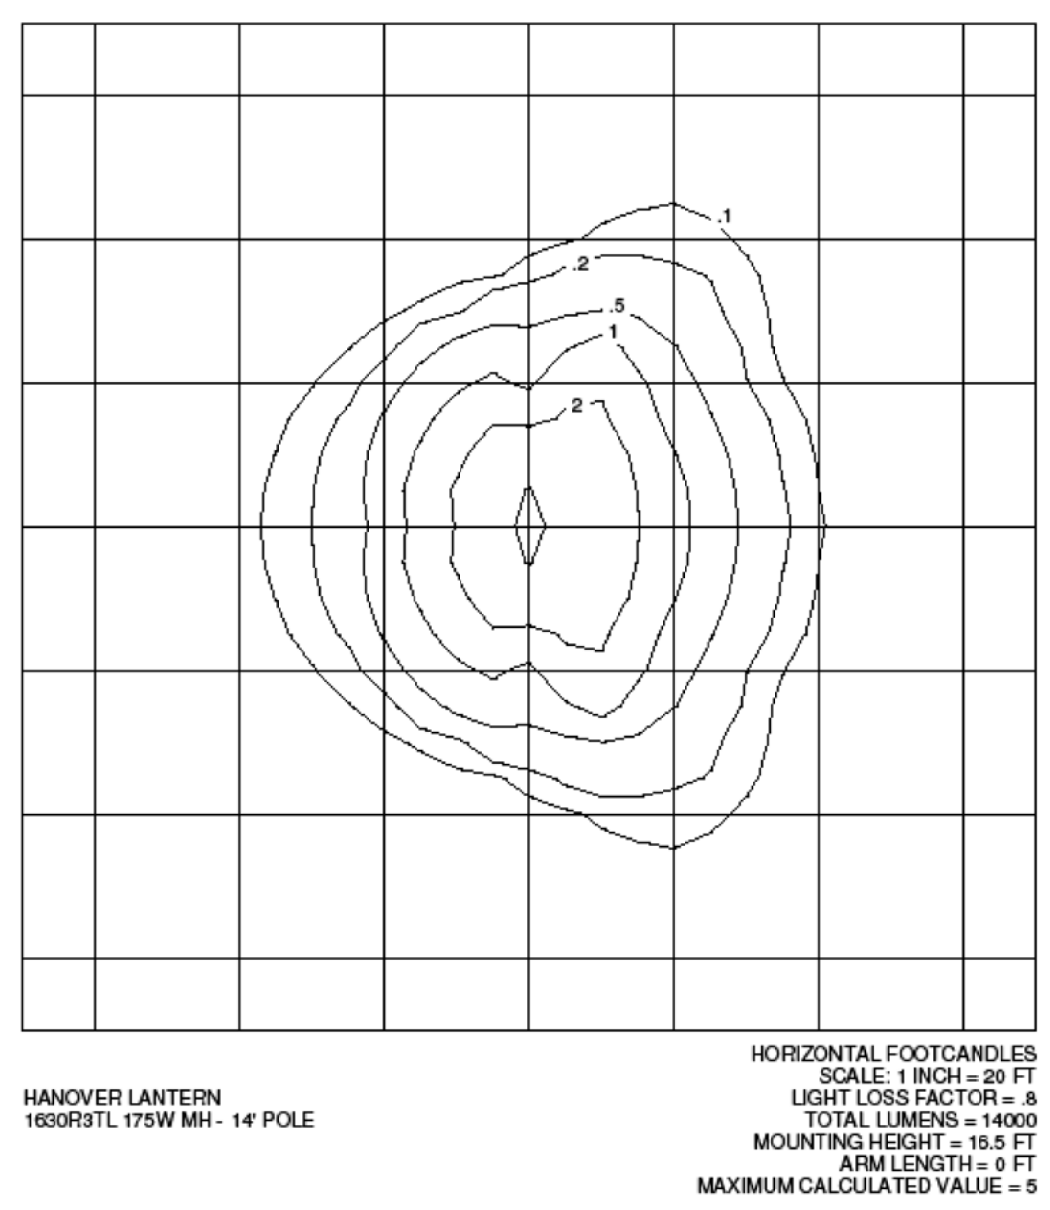

Luminaire Schedule						
Symbol	Qty	Label	Arrangement	Lumens	LLF	Description
□	62	SINGLE	SINGLE	14000	0.800	1630R3TL 175W MH - 14' POLE

Numeric Summary						
Label	ColType	Units	Avg	Max	Min	Avg/Min
HORIZ	Illuminance	Fc	1.37	4.59	0.19	7.21

Drawing for illustration only - scale approximate

ST. PETERS LIGHTING PLAN

072407

Rev.	Date	Description

OVERALL LIGHTING PLAN		PLAN OF SUBDIVISION FOR GRANITE VILLAGE AT SAINT PETERS	
WARWICK TOWNSHIP • CHESTER COUNTY • PENNSYLVANIA		EARTH ENTERPRISES	
1441 PRIZER ROAD		1441 PRIZER ROAD	
PUGHSTOWN, PA 19465		PUGHSTOWN, PA 19465	
Phone: (610) 469-8800		Date: 07/25/2007	
Fax: (610) 469-8900		Scale: 1" = 80'	
		Drawn: TAI	
		Checked: CAD	

1